


034HOP-7228
PALLETIZED FEED
TRANSITION HOPPER

034CNV-7230
SCREW CONVEYOR
TO KILN AUGER FEED

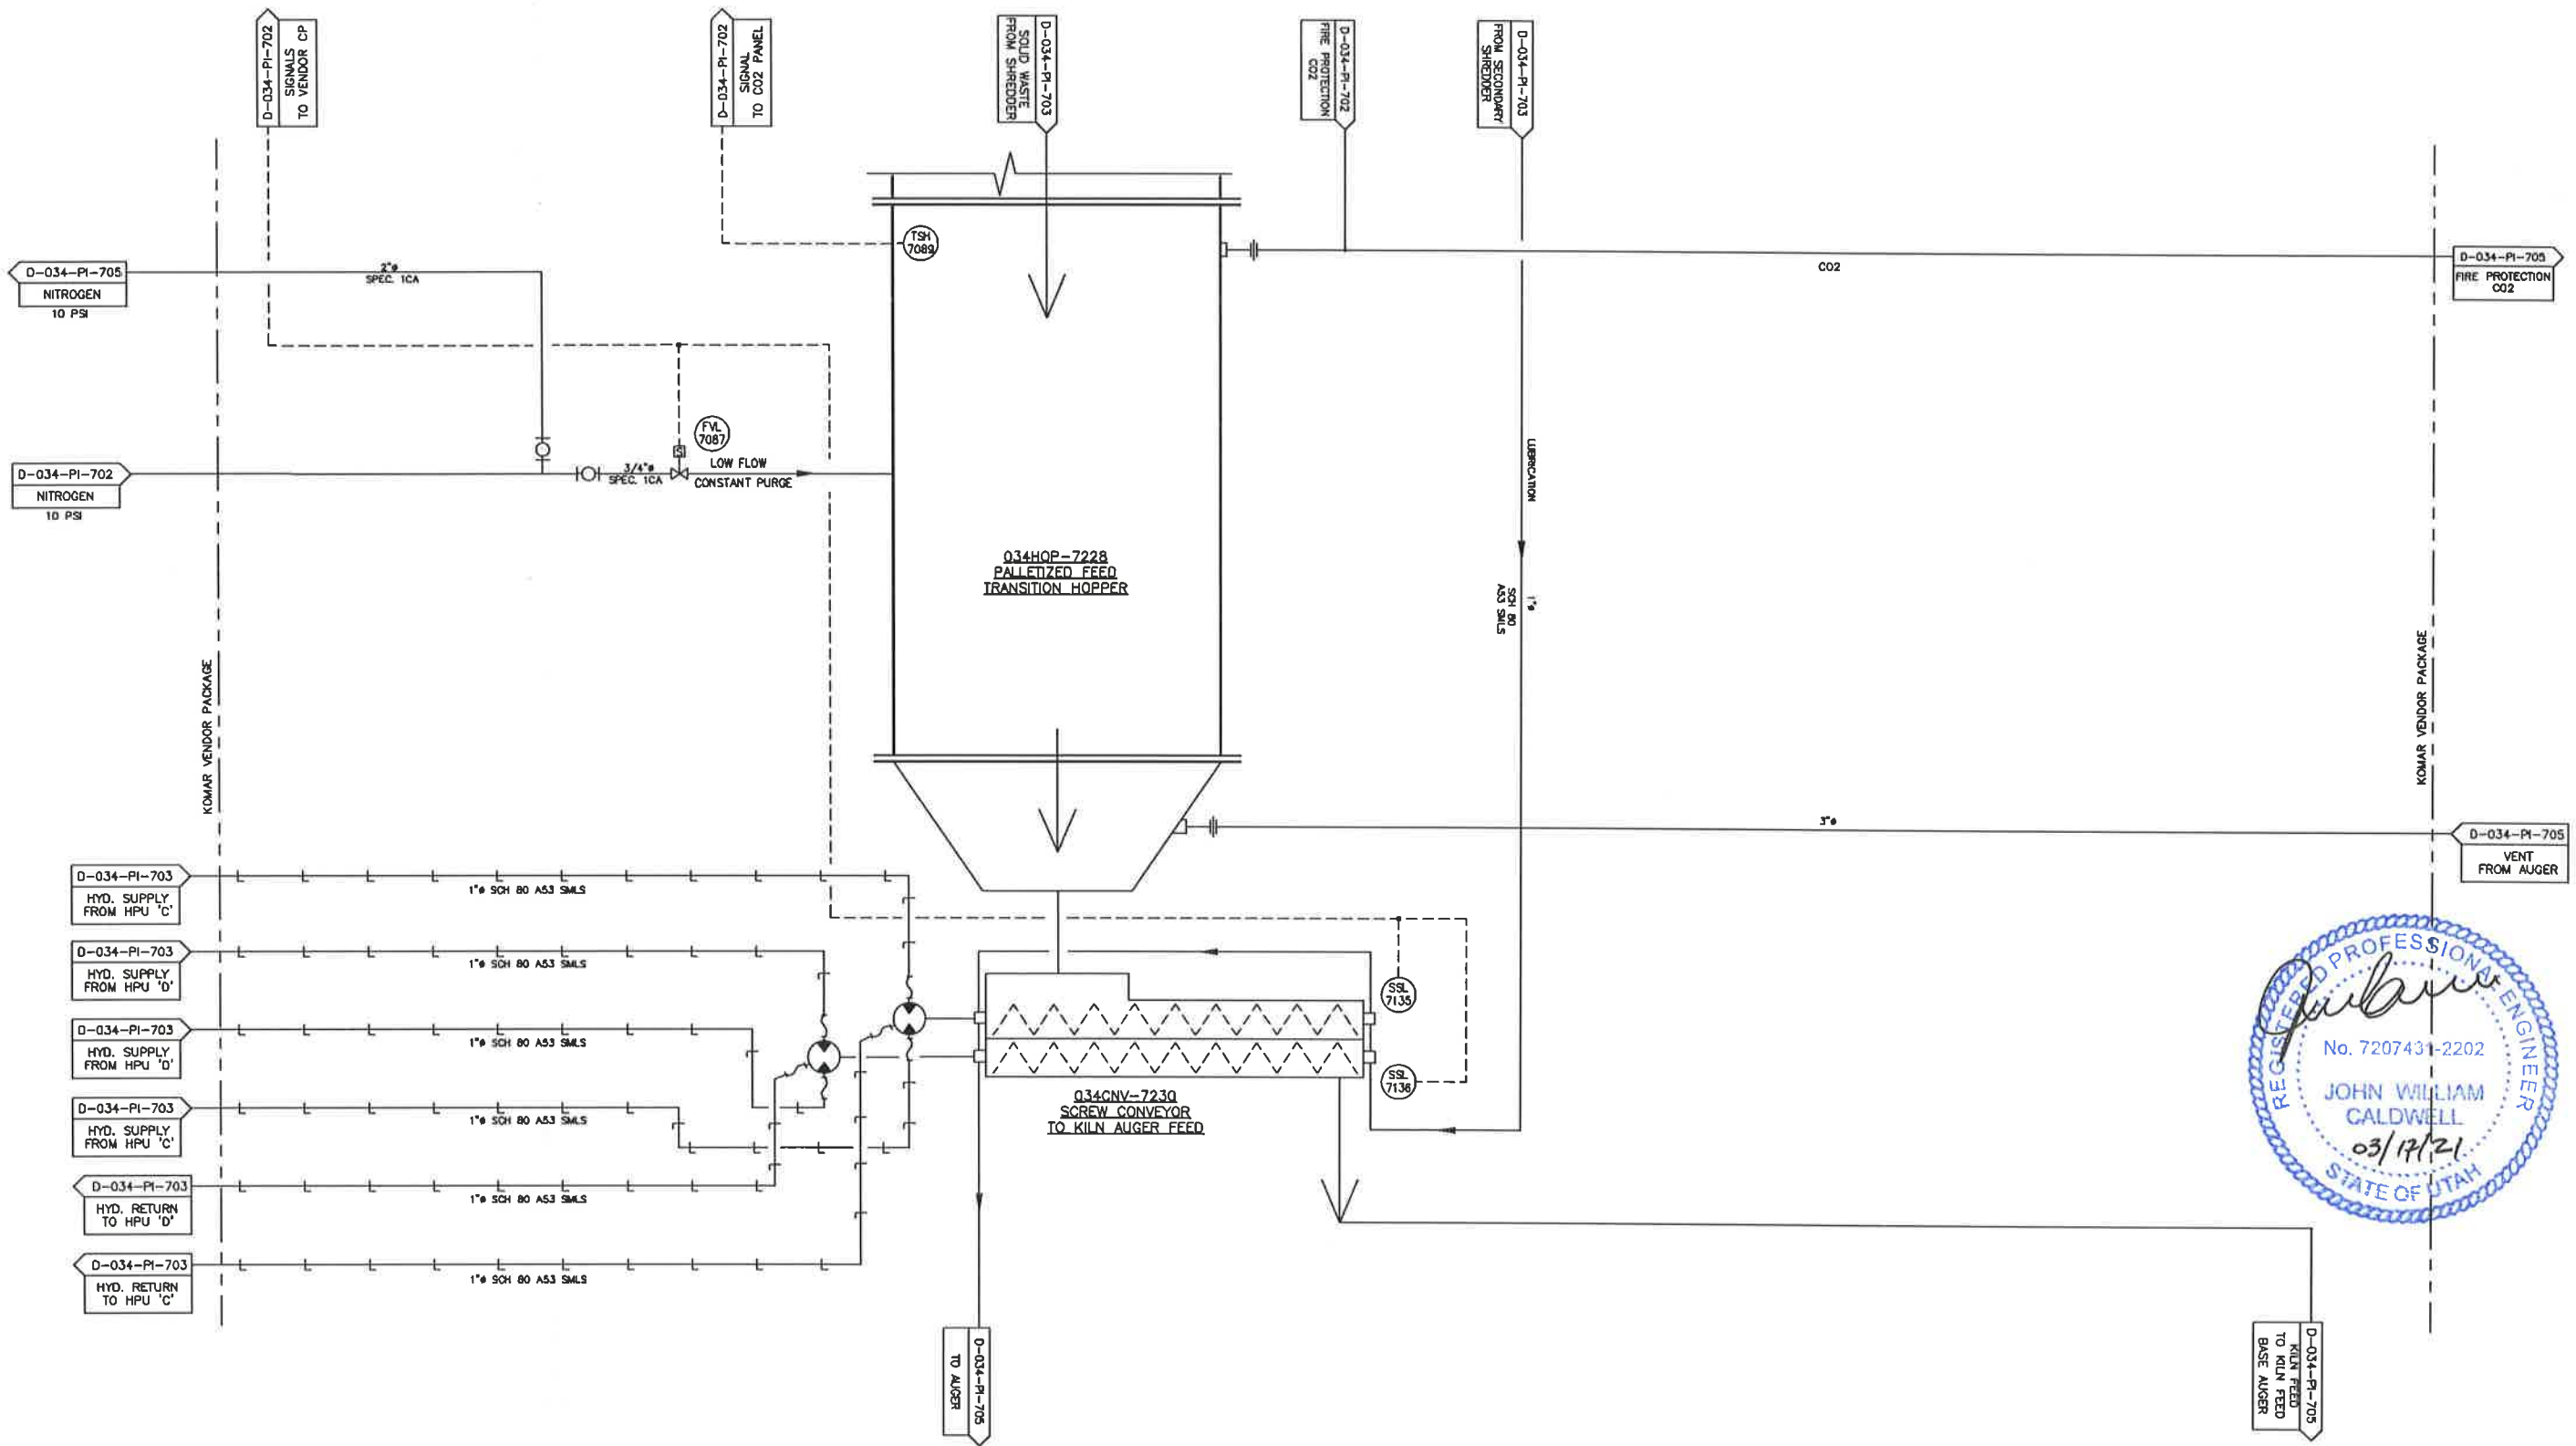

D-034-PI-704 FAP/AMP 6/8/20

INTERLOCK DESCRIPTION						REVISIONS					REVISIONS					APPROVALS			CleanHarbors® ARADOMITE LLC SHRED TOWER ADDITION PIPING & INSTRUMENTATION DIAGRAM SCREW CONVEYOR TO AUGER FEED			
NO	DESCRIPTION	DATE	BY	CHK	ENG MGR	NO	DESCRIPTION	DATE	BY	CHK	ENG MGR	BY	DATE	FOR	SCALE	TOWELE SITE	JOB NO	CAD NO.	D-034-PI-704	CLEANHARBORS DWG NO	REV	
1	GENERAL REVISIONS	02/08/19	PEC			1	REVISED LUBRICATION	6/8/20	PEC			PEC	11/28/18									
2	PERMIT	11/26/19	PEC			2	AS-BUILT DRAWING	3/12/21	MM													
3	GENERAL REVISIONS	12/2/19	PEC																			
4	GENERAL REVISIONS	12/6/19	PEC																			
5	ISSUE FOR ELECTRICAL BID REFERENCE	4/24/20	PEC																			

REGISTERED PROFESSIONAL ENGINEER
DATE: _____

FOR TOWELE SITE
SCALE NONE
JOB NO
CAD NO. D-034-PI-704
CLEANHARBORS DWG NO
REV 0