
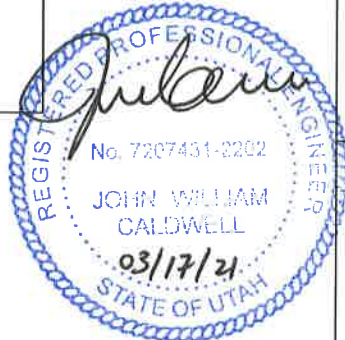


034HYS-7233 INJECTION AUGER HYDRAULIC SYSTEM
 034LUB-7232 SHREDDER #1 LUBRICATION SYSTEM
 034LUB-7229 SHREDDER #2 LUBRICATION SYSTEM
 034AUG-7235 KILN FEED BASE AUGER
 034ISO-7238 PALLETIZED FEED ISOLATION GATE

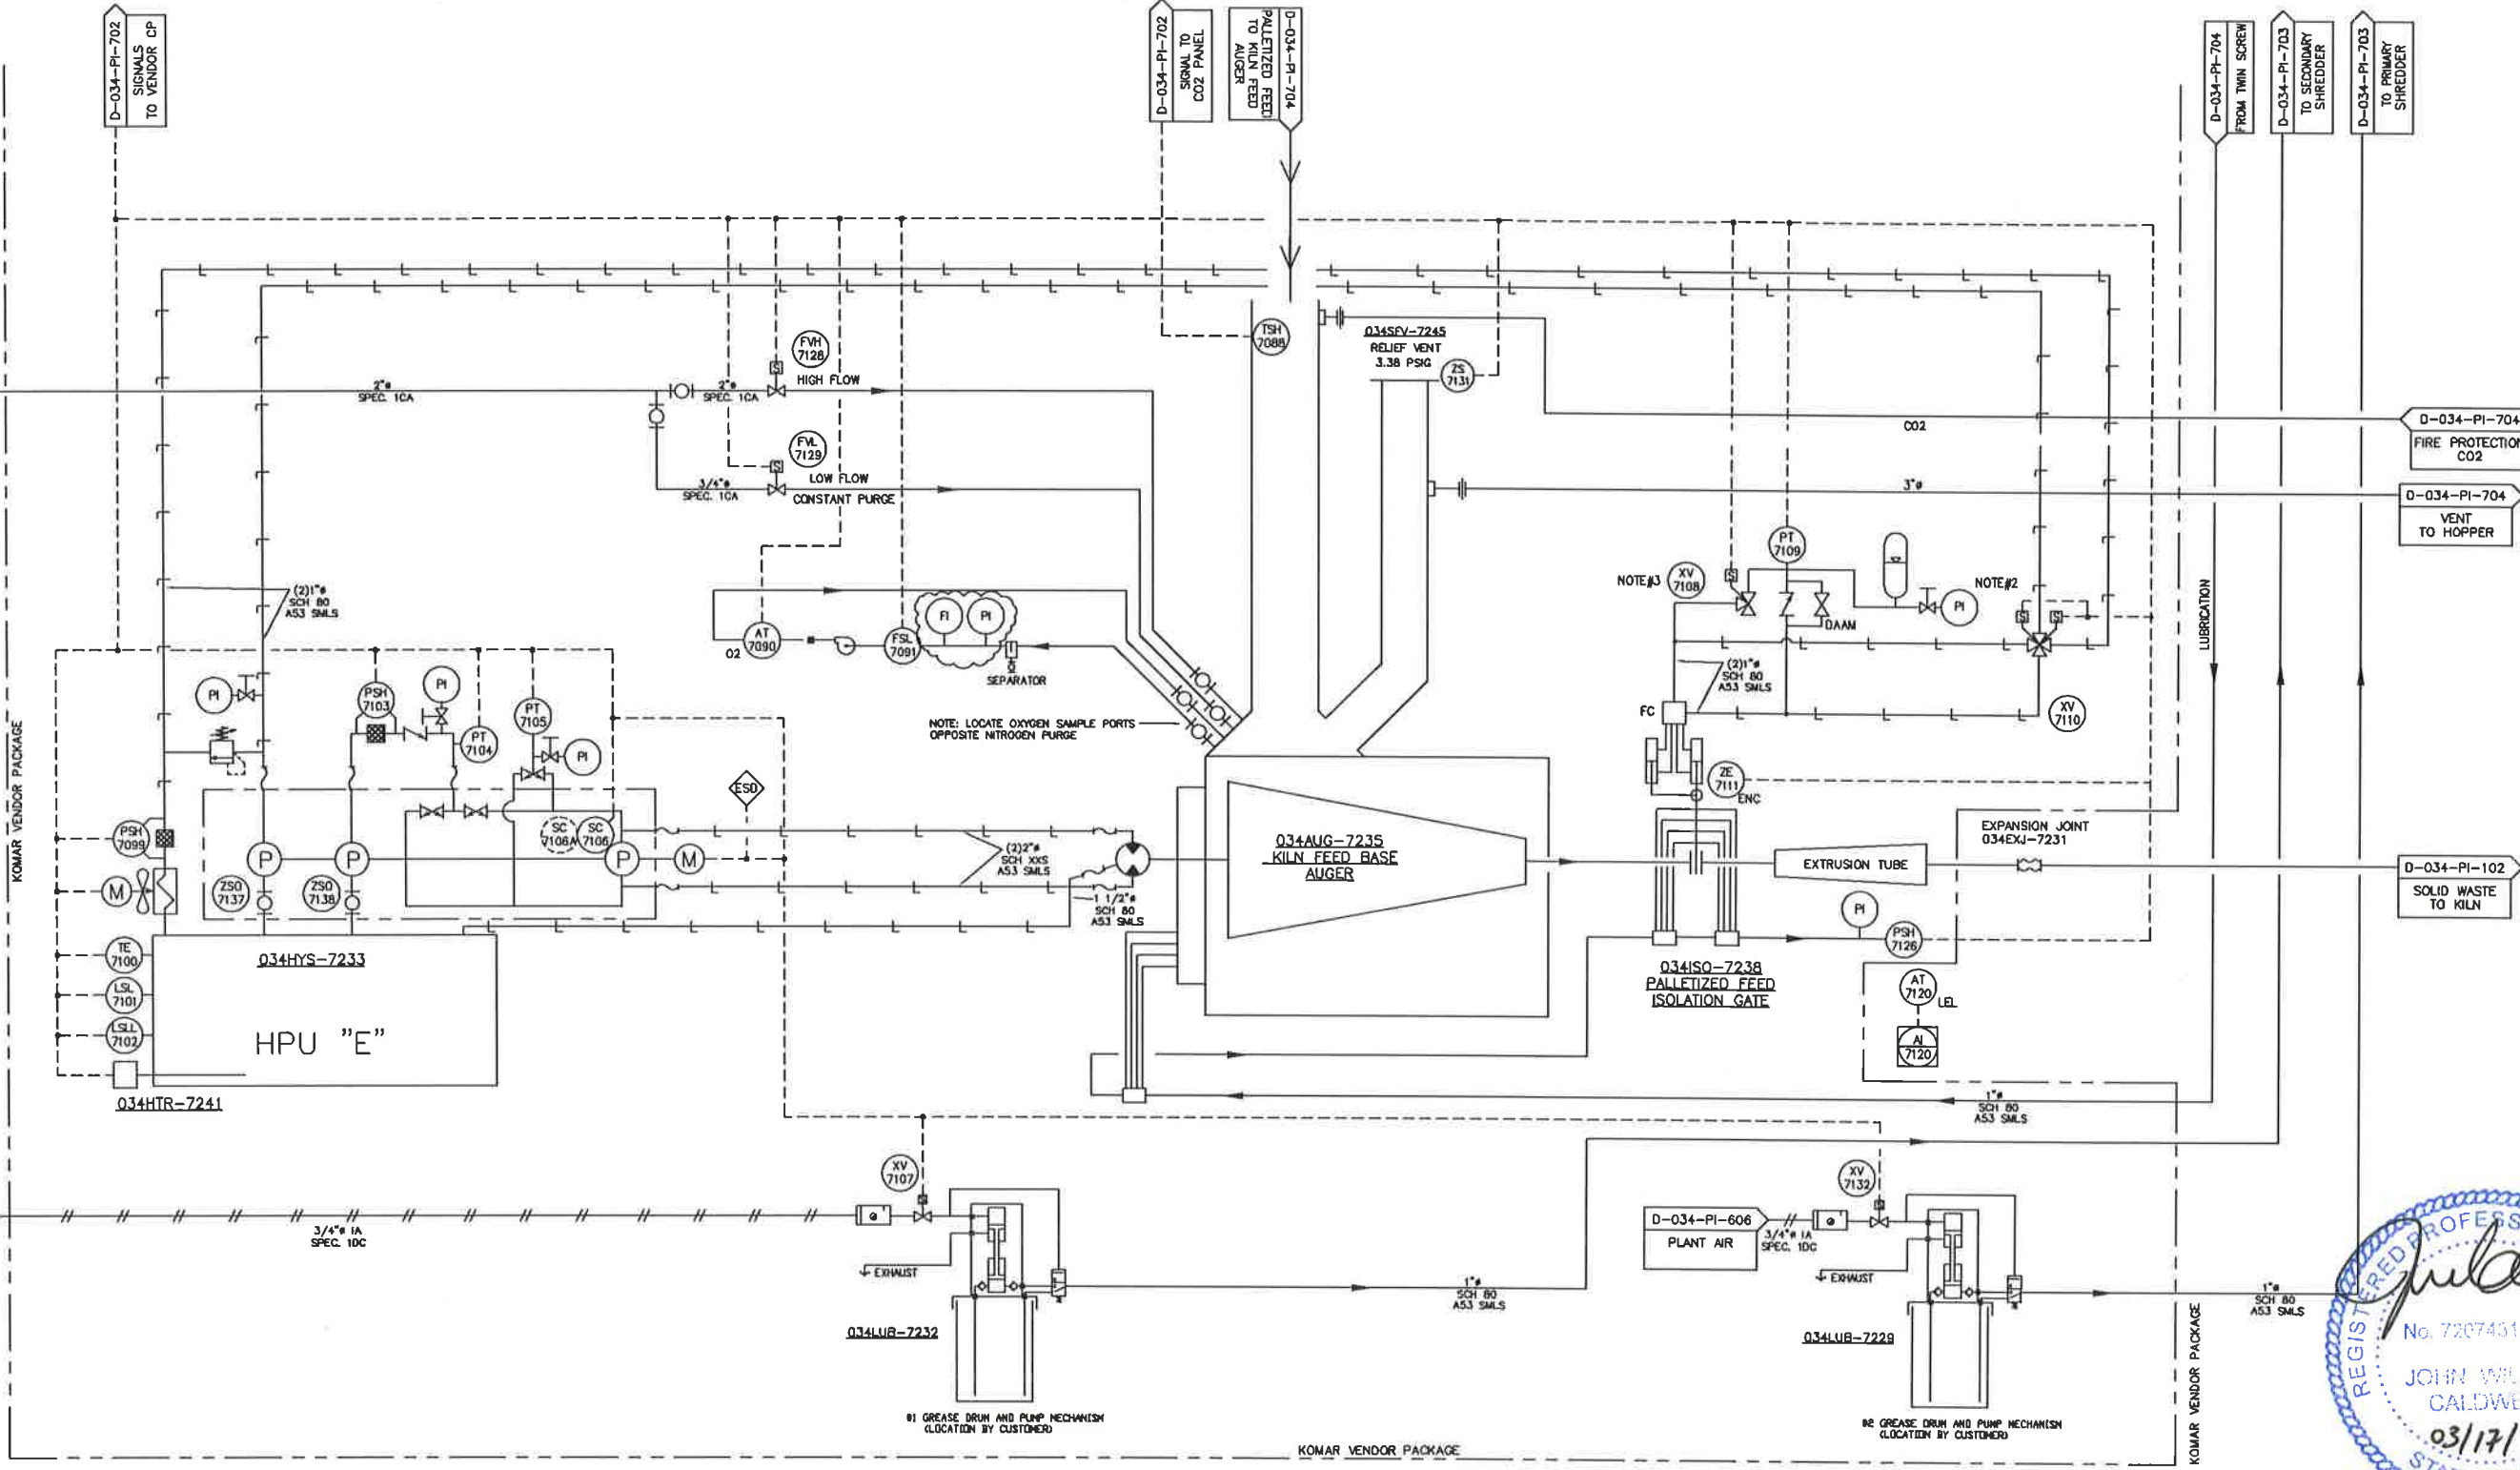

D-034-PI-705 FAP/WAP 5/6/20

INTERLOCK DESCRIPTION						REVISIONS						REVISIONS						APPROVALS			CleanHarbors			
NO	DESCRIPTION	DATE	BY	CHK	ENG MGR	NO	DESCRIPTION	DATE	BY	CHK	ENG MGR	DRAWN	BY	DATE	TITLE	FOR	SCALE	JOB NO	CAO NO.	CLEANHARBORS DWG NO	REV			
1	GENERAL REVISION	02/08/19				1	GENERAL REVISIONS	01/17/20	PEC			PEC	PEC	11/28/18	REGISTERED PROFESSIONAL ENGINEER	TOOLE SITE	NONE		D-034-PI-705					
2	PERMIT	11/26/19	PEC			2	ISSUE FOR ELECTRICAL BID REFERENCE	4/24/20	PEC															
3	GENERAL REVISIONS	12/2/19	PEC			3	REMOVED ZS-7130	4/28/20	PEC															
4	GENERAL REVISIONS	12/3/19	PEC			4	REVISED LUBRICATION	6/8/20	PEC															
5	GENERAL REVISIONS	12/6/19	PEC			5	AS-BUILT DRAWING	3/12/21	MM													0		

CleanHarbors
 DRAGONITE LLC
 1115 20th Street, Suite 200, Salt Lake City, UT 84143
 PHONE: 801-488-8888 FAX: 801-488-8889
 WWW.CLEANHARBORS.COM

TITLE: SHRED TOWER ADDITION PIPING & INSTRUMENTATION DIAGRAM KOMAR KILN FEED AUGER SYSTEM

FOR: TOOLE SITE CAO NO. D-034-PI-705
 SCALE: NONE JOB NO: CLEANHARBORS DWG NO: D-034-PI-705 REV: 0

REGISTERED PROFESSIONAL ENGINEER
 DATE: _____