

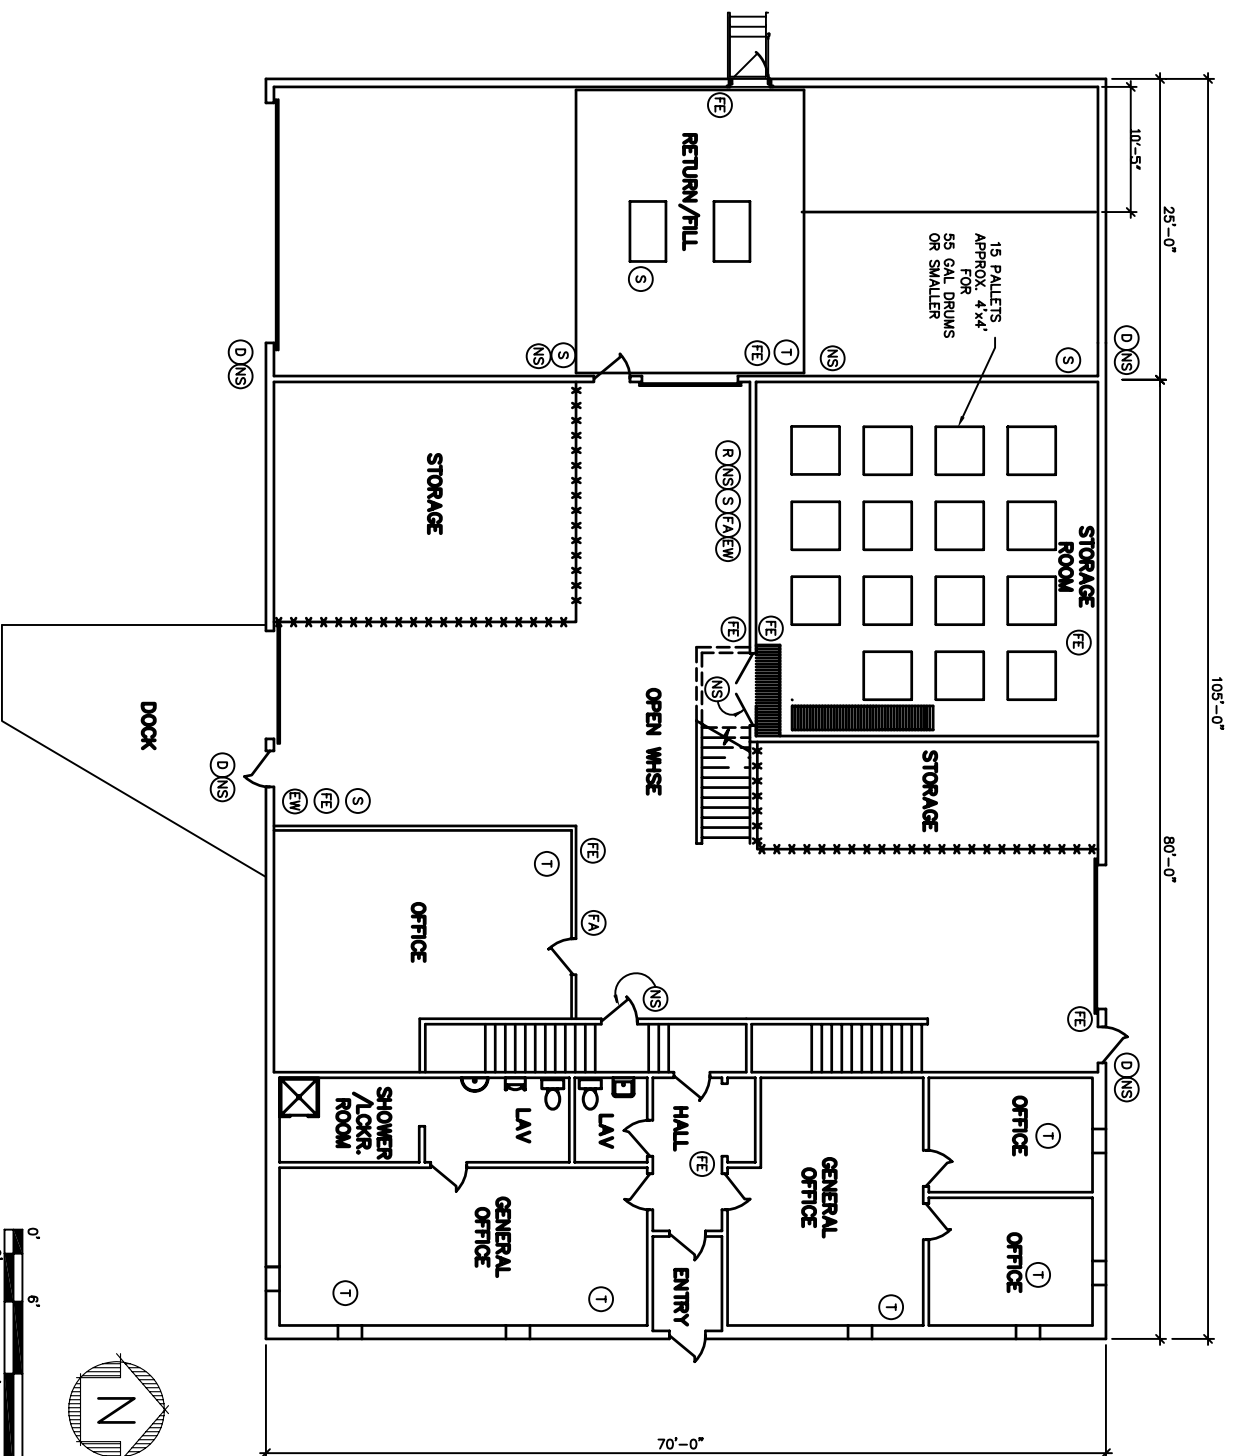


OFFICE, WHSE. & R/F FLOOR PLAN

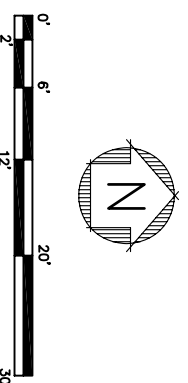

MEZZANINE FLOOR PLAN

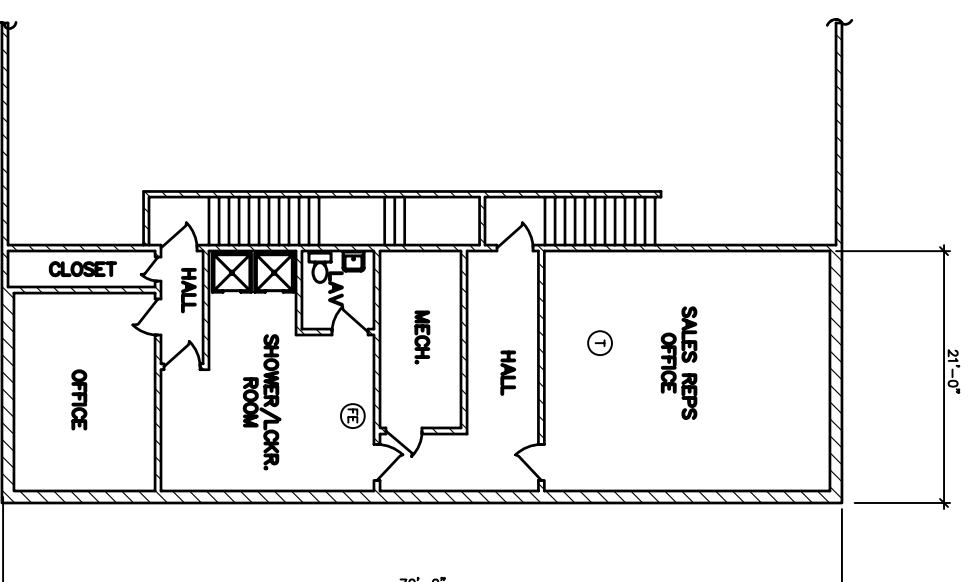

ATTACHMENT 3

NO.	DESCRIPTION	BY	CHK	APPR	DATE
G	REMOVE RECYCLE AREA	JEK	RS	RS	12/15/10
F	SHOW ASBUILT CONDITIONS	JEK	RS	RS	07/10/07
E	ADD RECYCLE SYSTEM AREA	JEK	RS	RS	6/17/07
D	ADD OFFICE AND REVISED EQR LOCATIONS	JEK	RS	RS	5/03/07
C	ADDED 15 PALLET'S IN STORAGE ROOM	ROK	KJM	WEY/CL	12/15/07
B	ADDED EGRESS DOOR IN R/F RELEASED TO CL FOR PERMIT MOD	MBH	KJM	WEY/CL	07/26/06
A	NEW RELEASE	MBH	KJM	WEY/CL	05/23/04

GENERAL NOTES

- NON-PERMITTED AREAS MAY CHANGE.
- ACTUAL EQUIPMENT LOCATION MAY VARY DUE TO CONSTRUCTION, MAINTENANCE AND/OR UPKEEP AT THE FACILITY.

LEGEND

- (R) RESPIRATORS
- (EW) EYE WASH
- (S) ABSORBENTS
- (T) TELEPHONE
- (FE) FIRE EXTINGUISHER
- (FA) FIRST AID STATION
- (D) DANGER SIGN
- (NS) NO SMOKING SIGN

OFFICE, WHSE. & R/F FLOOR PLAN SHOWING EMERGENCY EQUIPMENT LOCATIONS - EXISTING

S SAFETY-KLEEN SYSTEMS, INC.
 5400 LEGACY DR. CLUSTER II BLDG. 3 PLANO, TX. 75024 800-668-9740

SCALE 1/8" = 1'-0"
 BY MBH CHKD KJM
 SERVICE CENTER LOCATION
 SALT LAKE CITY, UT 716601-QAPB700
 DATE 05-23-04
 REV. NO. 6